

GENERAL NOTES

- 6'-0" WIDE WHITE BOARD
- SMART BOARD OF/CI
- STRUCTURE MOUNTED REAR FOLDING BASKETBALL BACKSTOP
- EYE WASH STATION
- VOLLEYBALL NET SLEEVES
- STRUCTURE MOUNTED FORWARD FOLDING BASKETBALL BACKSTOP
- AUTOMATIC DOOR OPERATOR
-
-
-
-
-
-

FLOOR PLAN LEVEL 1 - AREA C
 1/8" = 1'-0" A1

ARCHITECT
ksqdesign
 NEW YORK OKLAHOMA NORTH CAROLINA
 TEXAS COLORADO SOUTH CAROLINA
 KSQ Design
 1930 CAMDEN ROAD, SUITE 260
 CHARLOTTE, NC 28203
 704.364.3400 office
 704.364.7890 fax
 www.ksqdesign.com

Owner
BRUNSWICK COUNTY SCHOOLS
 198 SESSIONS DRIVE
 BOULDERIA, NC 28422
 910.755.5872 office
 www.bcswan.net

Civil Engineer
 MCGILL ASSOCIATES
 712 VILLAGE ROAD SW, SUITE 103
 SHALLOTTE, NC 28470
 910.755.5872 office
 www.mcgillengineer.com

Structural Engineer
 CRISER, TROUTMAN, TANNER
 3809 PEACHTREE AVE., SUITE 102
 WILMINGTON, NC 28403
 910.397.2971 office
 www.ctengineering.com

MEP Engineer
 KSQ DESIGN
 1930 CAMDEN ROAD, SUITE 260
 CHARLOTTE, NC 28203
 704.364.3400 office
 www.ksqdesign.com

Electrical Consultant
 QUALITY CONSULTING ENGINEERS, PLLC
 6277-600 CAROLINA COMMONS DRIVE,
 #350 INDIAN LAND SC 29707
 803.207.5450 office
 djones@qualityconsultingengineers.com

Acoustic & Technology Consultant
 THORBURN ASSOCIATES
 401 N. TYRON STREET, 10TH FLOOR
 CHARLOTTE, NC 28202
 510.886.7826 office
 www.TA-inc.com


Building Envelope Consultant
 SKA ENGINEERING
 7741 MARKET STREET, SUITE F
 WILMINGTON, NC 28411-9444
 910.442.2000 office
 www.skaeng.com

Food Service Consultant
 HERBIN DESIGN
 7325 DORN CIRCLE
 CHARLOTTE, NC 28212-6914
 704.900.0922
 www.herbin.com



TOWN CREEK MIDDLE SCHOOL

6370 LAKE PARK DRIVE SE
 WINNABOW, NC 28479

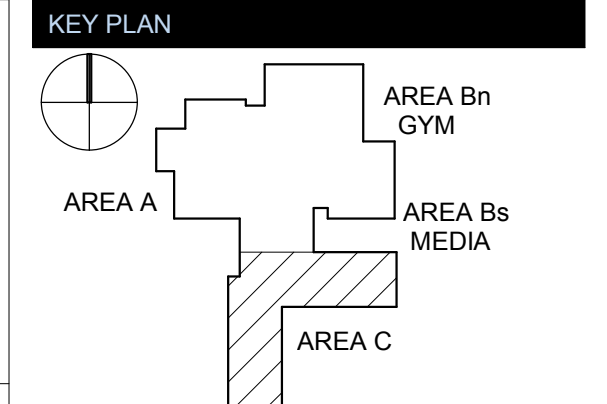

REVISIONS

No.	Description	Date
1	Addendum #1	6-7-2018
2	Addendum #2	6-19-2018

ISSUED: CONSTRUCTION DOCUMENTS

DATE: 05/24/2018
SCALE: 1/8" = 1'-0"
SHEET NAME:
FLOOR PLAN LEVEL 1 - AREA C

SHEET NUMBER:
A-101C