

PERFORATED EXHAUST DIFFUSER table with columns SYM, DESCRIPTION, TYPE. Includes notes on acceptable manufacturers and maximum NC values.

PERFORATED SUPPLY DIFFUSER table with columns SYM, DESCRIPTION, TYPE. Includes notes on acceptable manufacturers and maximum NC values.

PERFORATED RETURN DIFFUSER table with columns SYM, DESCRIPTION, TYPE. Includes notes on acceptable manufacturers and maximum NC values.

ENERGY RECOVERY VENTILATOR SCHEDULE table with columns TAG, LOCATION, OUTSIDE AIR CFM, SUPPLY EXT. S.P., EXHAUST EXT. S.P., etc. Includes notes on unit mounting and controls.

PERFORATED RETURN PANEL table with columns SYM, DESCRIPTION, TYPE. Includes notes on acceptable manufacturers and maximum NC values.

BLADE SUPPLY GRILLES table with columns SYM, MODULE SIZE, TYPE. Includes notes on acceptable manufacturers and maximum NC values.

SIDEWALL RETURN GRILLE table with columns SYM, MODULE SIZE, TYPE. Includes notes on acceptable manufacturers and maximum NC values.

GRAVITY VENTILATOR SCHEDULE table with columns TAG, SERVICE, LOCATION, CFM, THROAT SIZE, HOOD SIZE, HEIGHT, DAMPER, ROOF CURB, MANUFACTURER AND MODEL, NOTES.

EGG CRATE RETURN PANEL table with columns SYM, DESCRIPTION, TYPE. Includes notes on acceptable manufacturers and maximum NC values.

SPIRAL DUCT MOUNTED SUPPLY GRILL table with columns SYM, DESCRIPTION, TYPE. Includes notes on acceptable manufacturers and maximum NC values.

SUPPLY DUCT - SOUND ATTENUATOR SCHEDULE

SUPPLY DUCT - SOUND ATTENUATOR SCHEDULE table with columns TAG, LOCATION, SIZE, DIL @ DUCT VELOCITY, GENERATED NOISE @ DUCT VELOCITY, AIR FLOW, VELOCITY, PRESSURE DROP, MANUFACTURER, MODEL, NOTES.


RETURN DUCT - SOUND ATTENUATOR SCHEDULE

RETURN DUCT - SOUND ATTENUATOR SCHEDULE table with columns TAG, LOCATION, SIZE, DIL @ DUCT VELOCITY, GENERATED NOISE @ DUCT VELOCITY, AIR FLOW, VELOCITY, PRESSURE DROP, MANUFACTURER, MODEL, NOTES.


FAN SCHEDULE

FAN SCHEDULE table with columns TAG, SERVICE, LOCATION, CFM, FAN RPM, STATIC PRESSURE, MAX TIP SPEED, MIN WHEEL DIA, FAN WHEEL TYPE, MOTOR HP/VOLT/PHASE, DRIVE TYPE, FAN TYPE, MAX SONES, WEIGHT (LBS), MANUFACTURER AND MODEL NUMBER, NOTES.

ARCHITECT: ksqdesign. NC-ENG LICENSE NO. C-064. NEW YORK, OKLAHOMA, NORTH CAROLINA, TEXAS, COLORADO, SOUTH CAROLINA. KSO Design, 1550 CAMDEN ROAD, SUITE 260, CHARLOTTE, NC 28203. BRUNSWICK COUNTY SCHOOLS, 1550 CAMDEN ROAD, SUITE 260, CHARLOTTE, NC 28203. THORBURN ASSOCIATES, 401 N. TYRON STREET, 10TH FLOOR, CHARLOTTE, NC 28202. TOWNSHIP OF LENOIR, 1000 W. HUNTER STREET, SUITE 100, HUNTER, NC 28544.

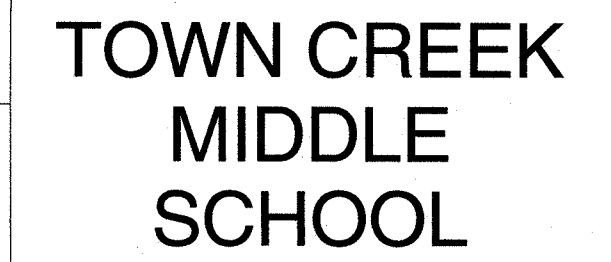

TOWN CREEK MIDDLE SCHOOL

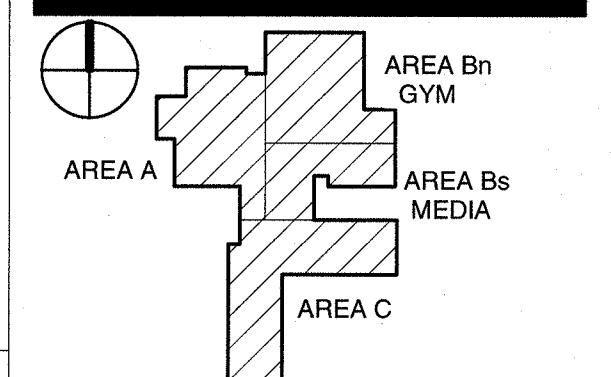

REVISIONS table with columns No., Description, Date. Includes revision 2: ADDENDUM 2, 6/18/2018.

ISSUED: CONSTRUCTION DOCUMENTS. DATE: 05/24/2018. SCALE: 1/2" = 1'-0". SHEET NAME: MECHANICAL SCHEDULES. SHEET NUMBER: M-502.