

1 WASTE & VENT FLOOR PLAN LEVEL 1 - AREA C  
1/8" = 1'-0"

ARCHITECT



NC-ENG-LICENSE NO.: C-4064  
NEW YORK OKLAHOMA NORTH CAROLINA  
TEXAS COLORADO SOUTH CAROLINA

**KSQ Design**  
1830 CAMDEN ROAD, SUITE 260  
CHARLOTTE, NC 28203  
704.364.3400 office  
704.364.7080 fax  
www.ksqdesign.com

**Owner**  
**BRUNSWICK COUNTY SCHOOLS**  
199 SESSIONS DRIVE  
BOLIVIA, NC 28422  
910.253.2900 office  
www.bcsd.net

**Civil Engineer**  
MCGILL ASSOCIATES  
715 VILLAGE ROAD SW, SUITE 103  
SHALLOTTE, NC 28470  
910.755.5972 office  
www.mcgillengineer.com

**Structural Engineer**  
CRISER, TROUTMAN, TANNER  
3809 PEACHTREE AVE., SUITE 102  
WILMINGTON, NC 28403  
910.397.2911 office  
www.ctengineering.com



**MEP Engineer**  
KSO DESIGN  
1830 CAMDEN ROAD, SUITE 260  
CHARLOTTE, NC 28203  
704.364.3400 office  
NC-ENG-LICENSE NO.: C-4064

**Electrical Consultant**  
Quality Consulting Engineers, PLLC  
6277 45th Carolina Commons Drive, #350  
Indian Land SC 29707

**Acoustic & Technology Consultant**  
THORBURN ASSOCIATES  
401 N. TYRON STREET, 10TH FLOOR  
CHARLOTTE, NC 28202  
510.886.7828 office  
www.TA-inc.com


**Building Envelope Consultant**  
SKA ENGINEERING  
7741 MARKET STREET, SUITE F  
WILMINGTON, NC 28411-9444  
910.442.2000 office  
www.skaeng.com

**Food Service Consultant**  
HERBIN DESIGN  
7255 DORN CIRCLE  
CHARLOTTE, NC 28212-6914  
704.900.0922  
www.herbin.com

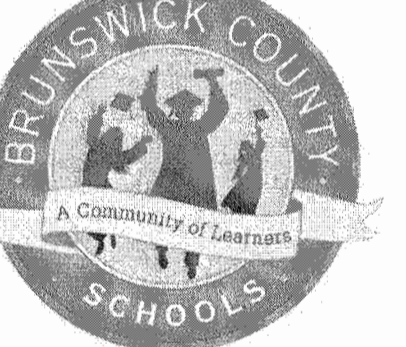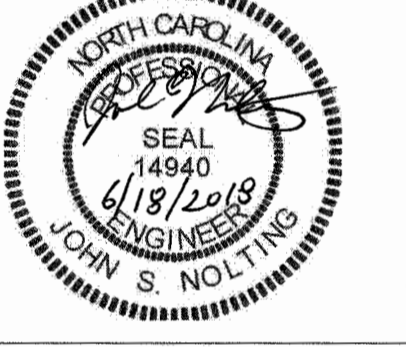

**TOWN CREEK MIDDLE SCHOOL**

6370 LAKE PARK DRIVE SE  
WINNABOW, NC 28479

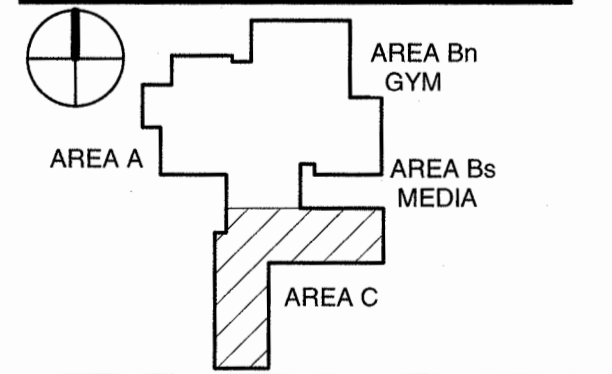

REVISIONS

No.	Description	Date
1	ADDENDUM 1	6/7/2018
2	ADDENDUM 2	6/18/2018

ISSUED: CONSTRUCTION DOCUMENTS  
DATE: 05/24/2018  
SCALE: 1/8" = 1'-0"  
SHEET NAME: WASTE AND VENT FLOOR PLAN - LEVEL 1 - AREA C  
SHEET NUMBER:

**P-101C**